


EAST ELEVATION
SCALE 1:50

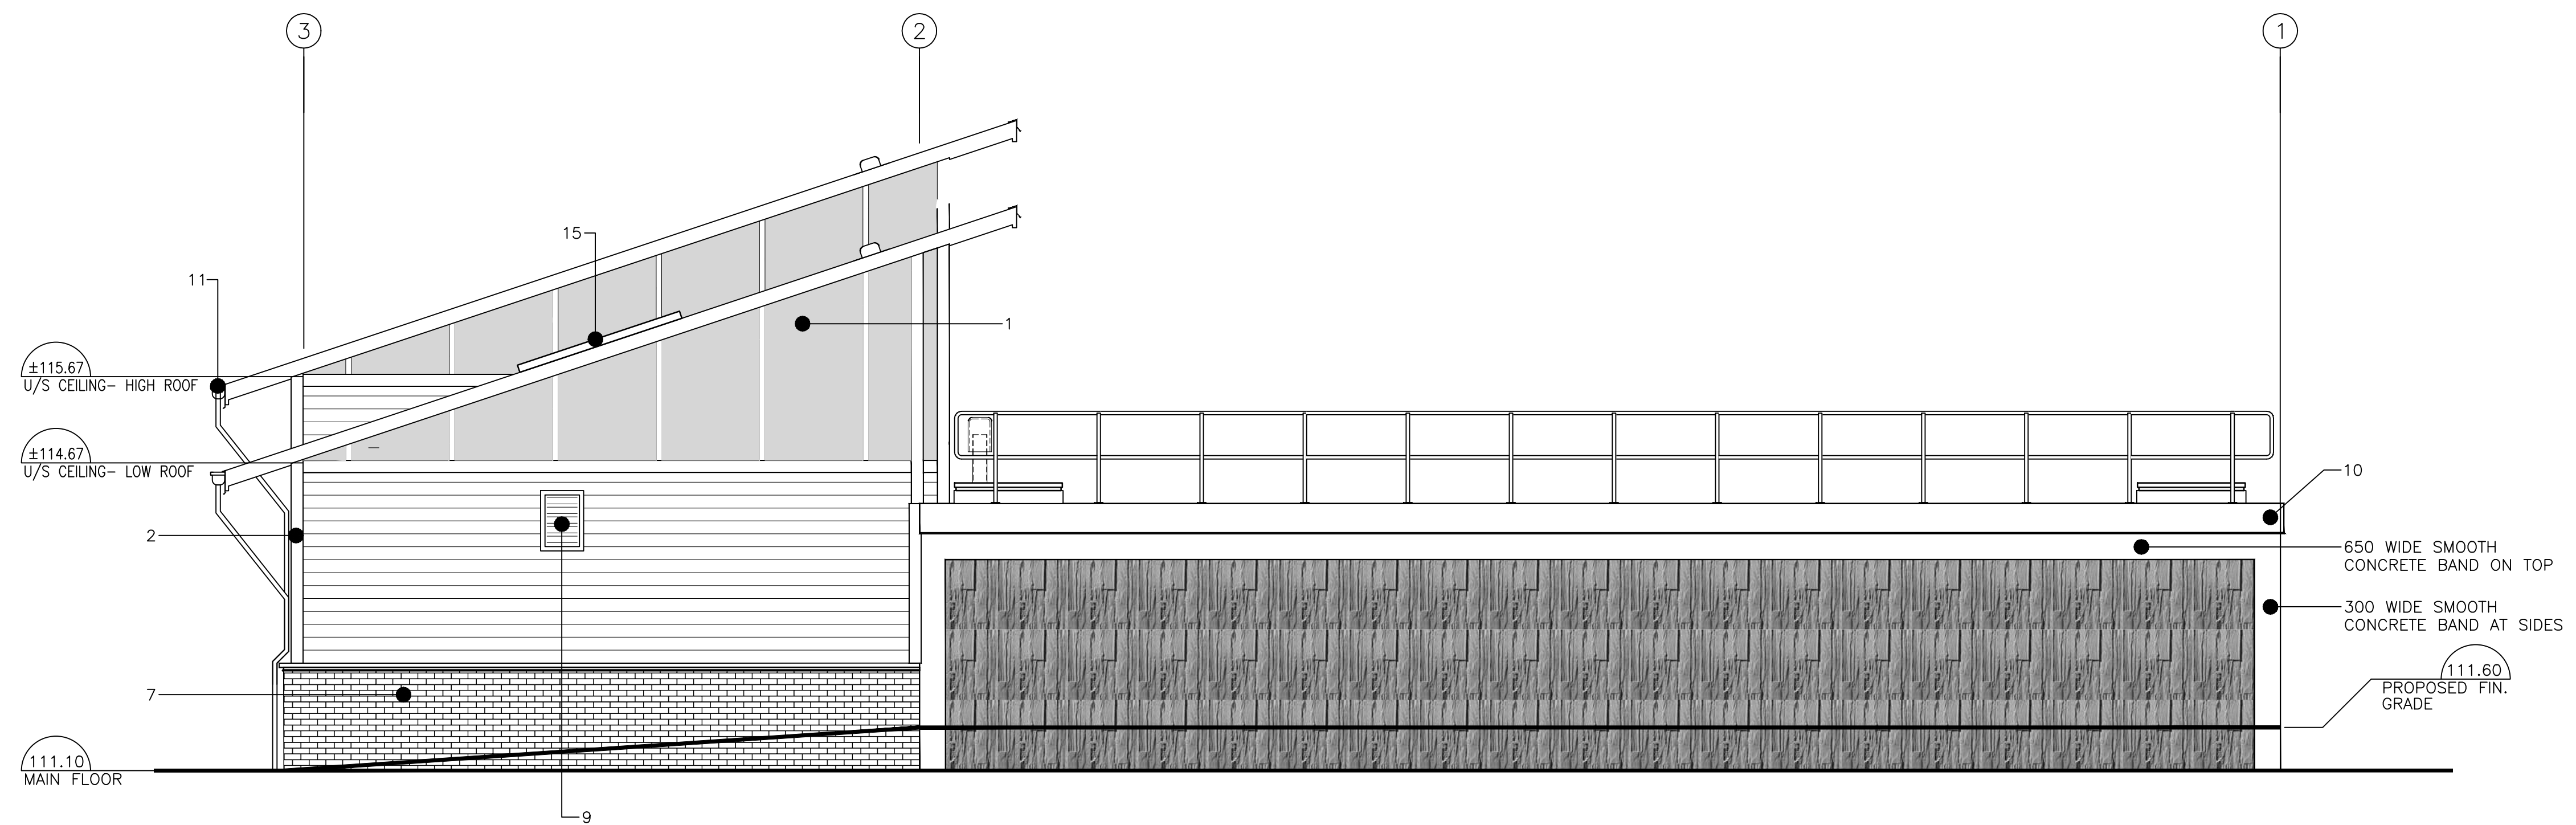

NORTH ELEVATION
SCALE 1:50

Path: G:\P\SECTION.DWG, EL Merklin, 01.DWG, 11700444_A201.DWG
 Drawing: U:\11711700444\DRAWINGS\MERKLIN_SITE\ARCHITECTURAL\11700444_A201.DWG
 December 01, 2015 8:22 a.m.

DRAWING No.	DRAWING TITLE	No.	DESCRIPTION	DATE	BY
	REFERENCE DRAWING				
			REVISION		

PERMIT STAMP	

ENGINEERING STAMP	


WHITE ROCK
 CONSULTANT/CONTRACTOR:

Stantec
 Stantec Consulting Ltd.
 10th Floor 13401 - 108th Avenue
 Surrey BC Canada
 V3T 5T3
 Tel: 604.587.8400
 Fax: 604.587.8469
 www.stantec.com

SCALE:	1:50	-
DRAWN BY:	RJA	-
DESIGNED BY:	SSG	-
CHECKED BY:	RKC	-
APPROVED BY:	-	-
ENGINEER:		
OPERATIONS:		
MAINTENANCE:		

PLANT SITE: MERKLIN SITE		PLANT AREA:	
PROJECT NAME: WHITE ROCK WATER UTILITY - WATER SYSTEM UPGRADE			
DRAWING TITLE: PUMP STATION & RESERVOIR ELEVATIONS			
CONSULTANT JOB NO.	DMS DOC. No.	PROJECT No.	DRAWING No.
111700444		230995	A202
REV.	SHT.		
G			